



FRONT ELEVATION

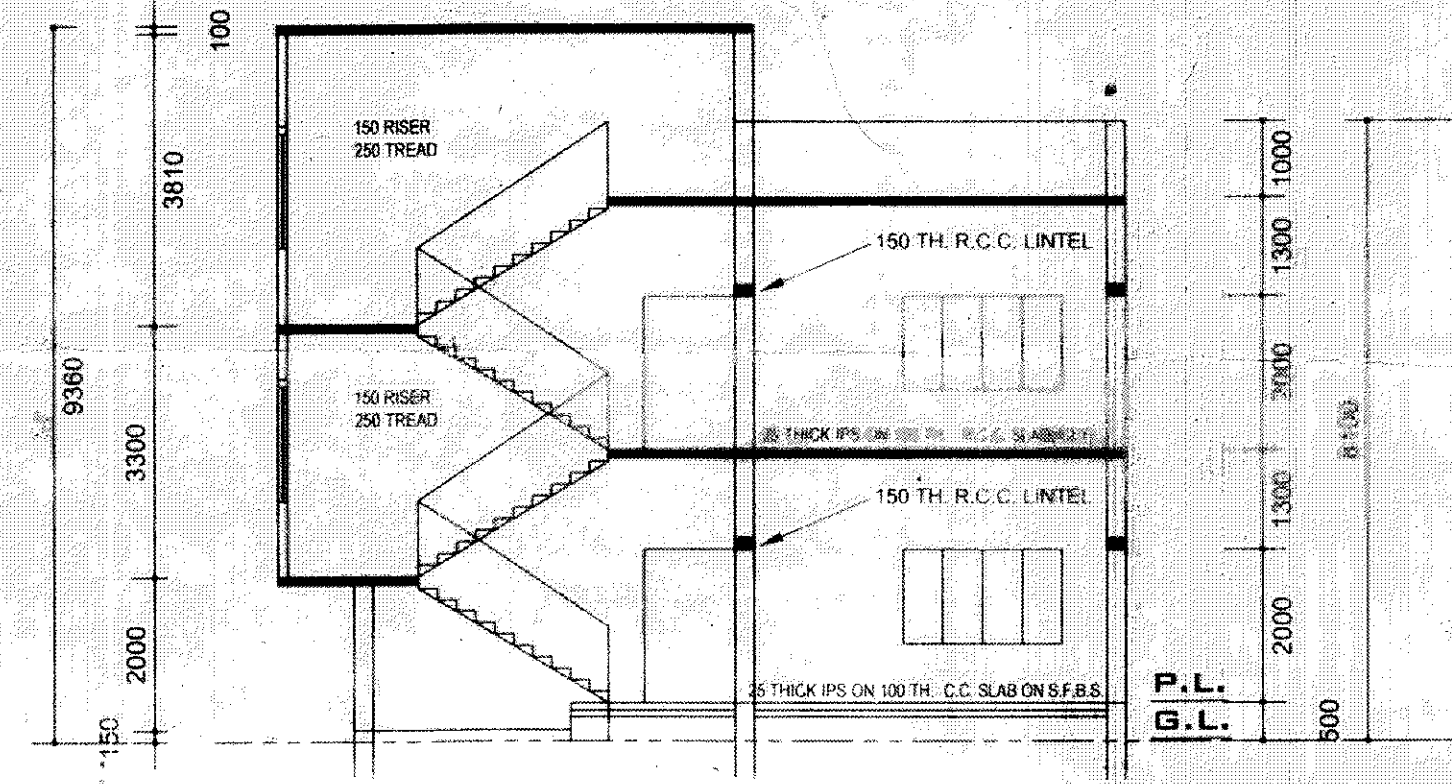


SECTION A - A


Signature
27/15
Assistant Engineer
Durgapur Municipal Corporation

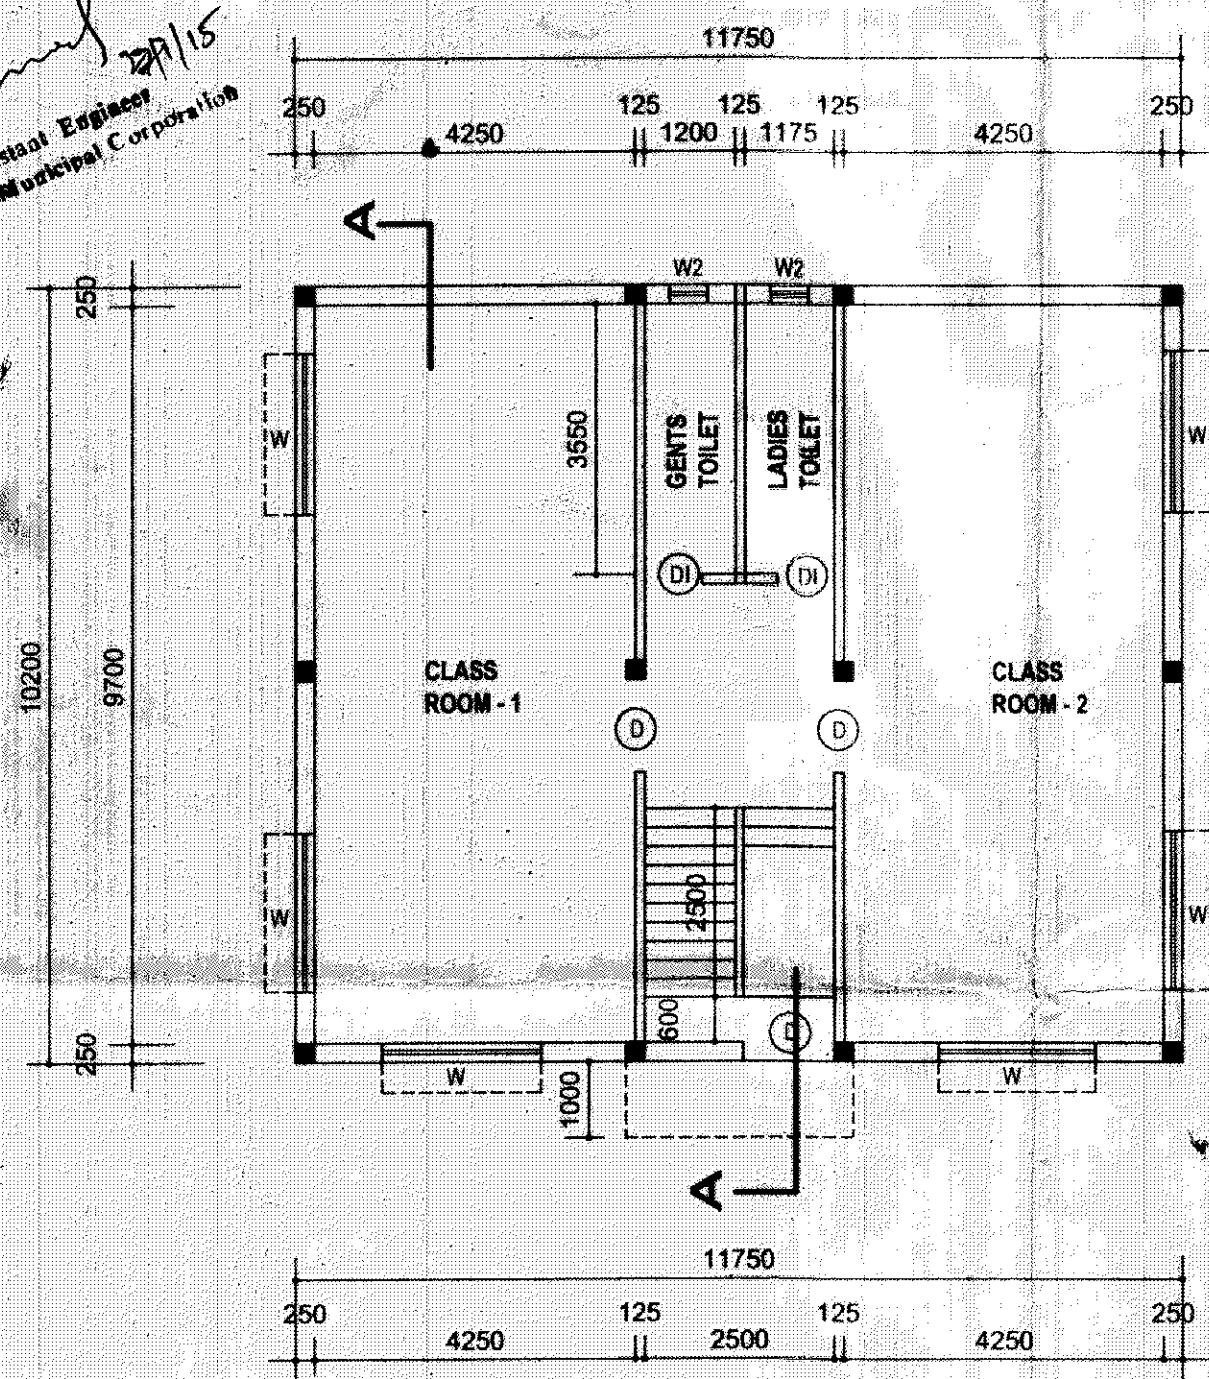



GROUND FLOOR PLAN

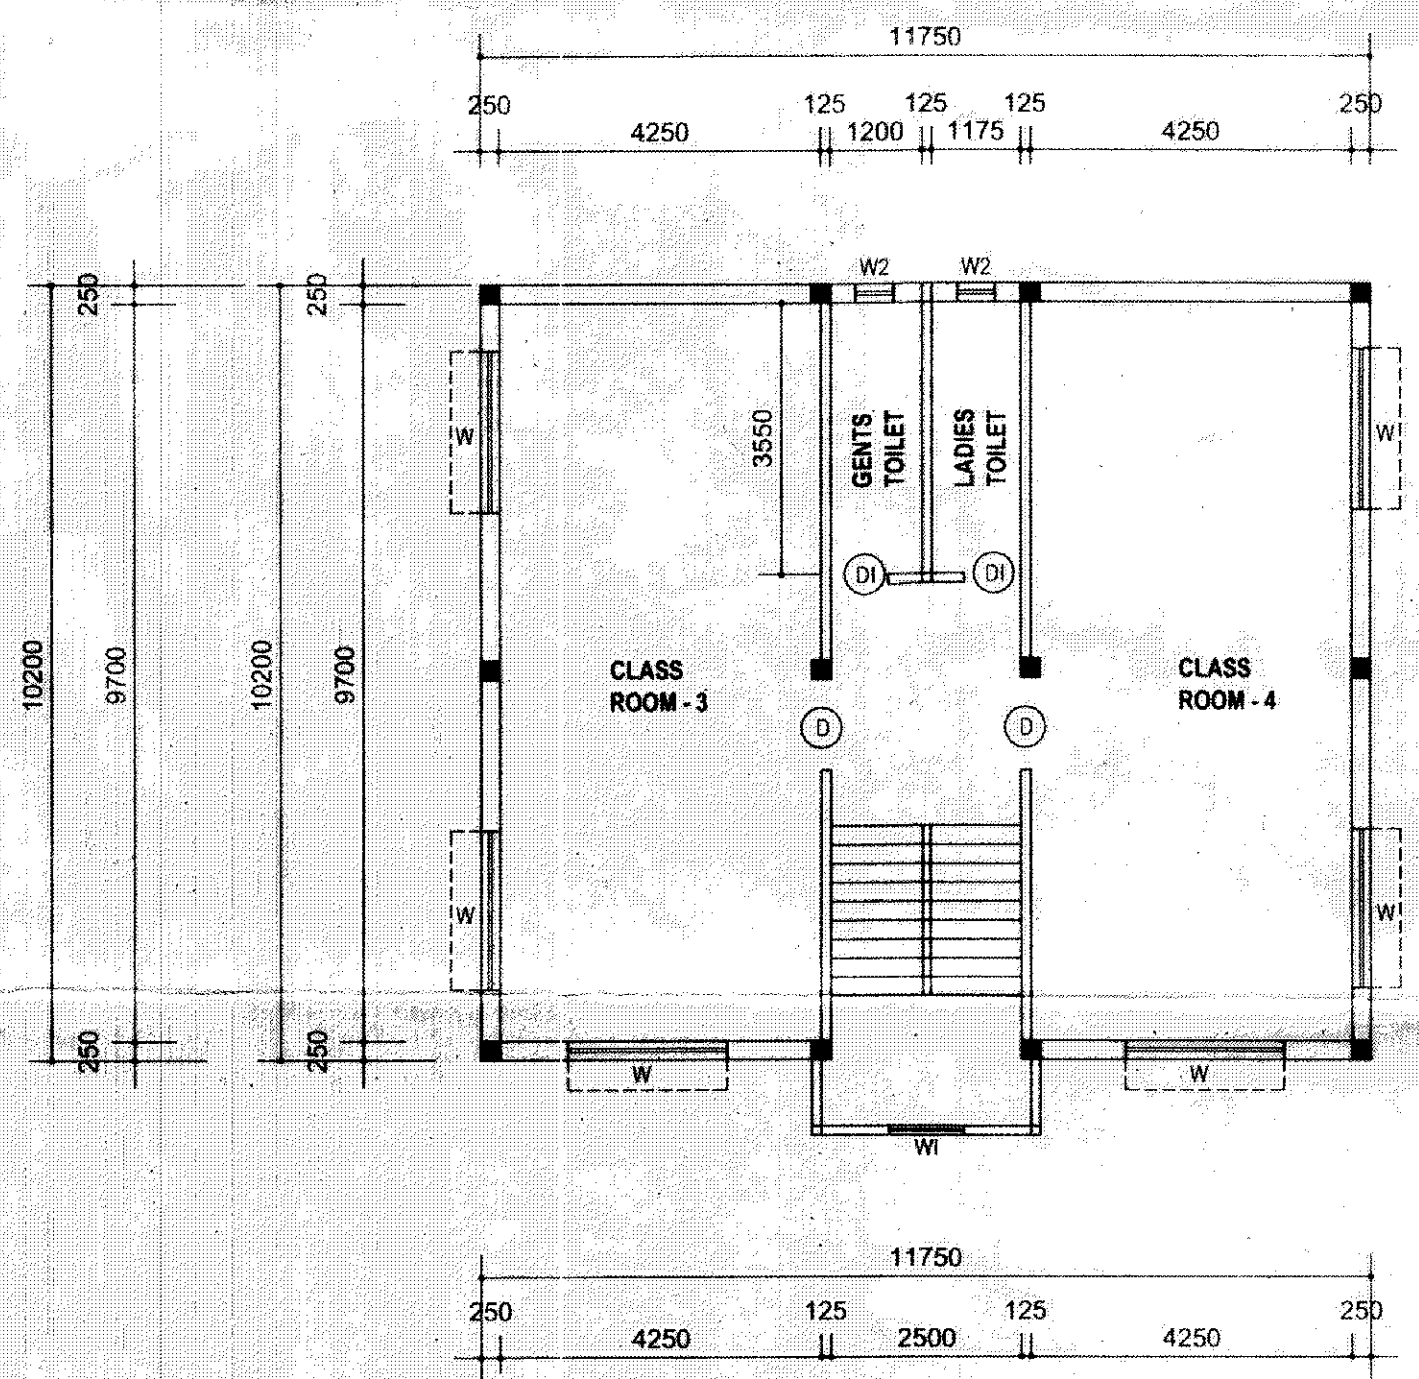

FIRST FLOOR PLAN

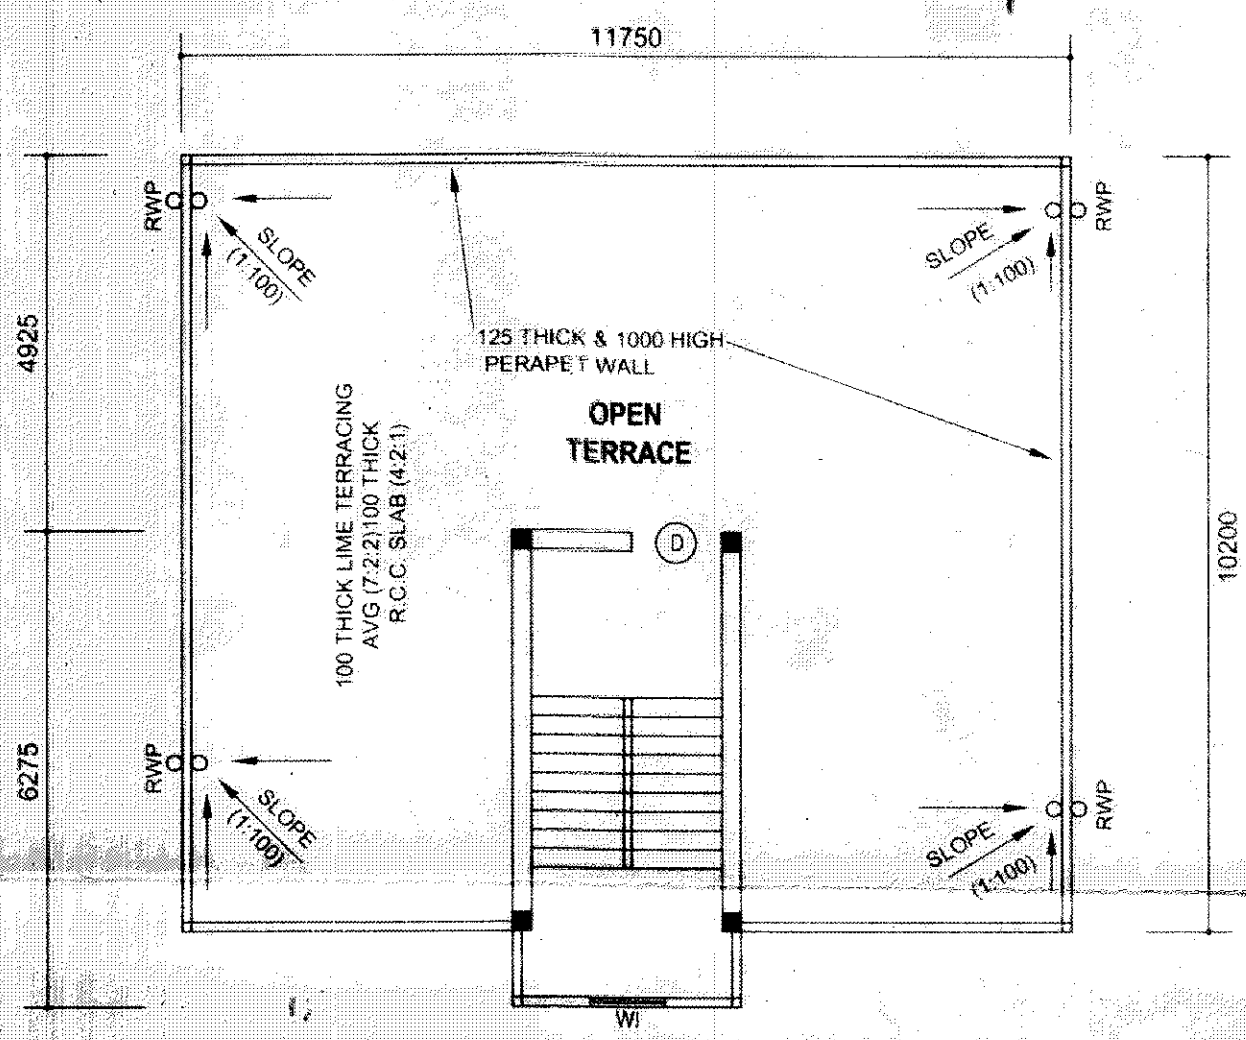

ROOF PLAN

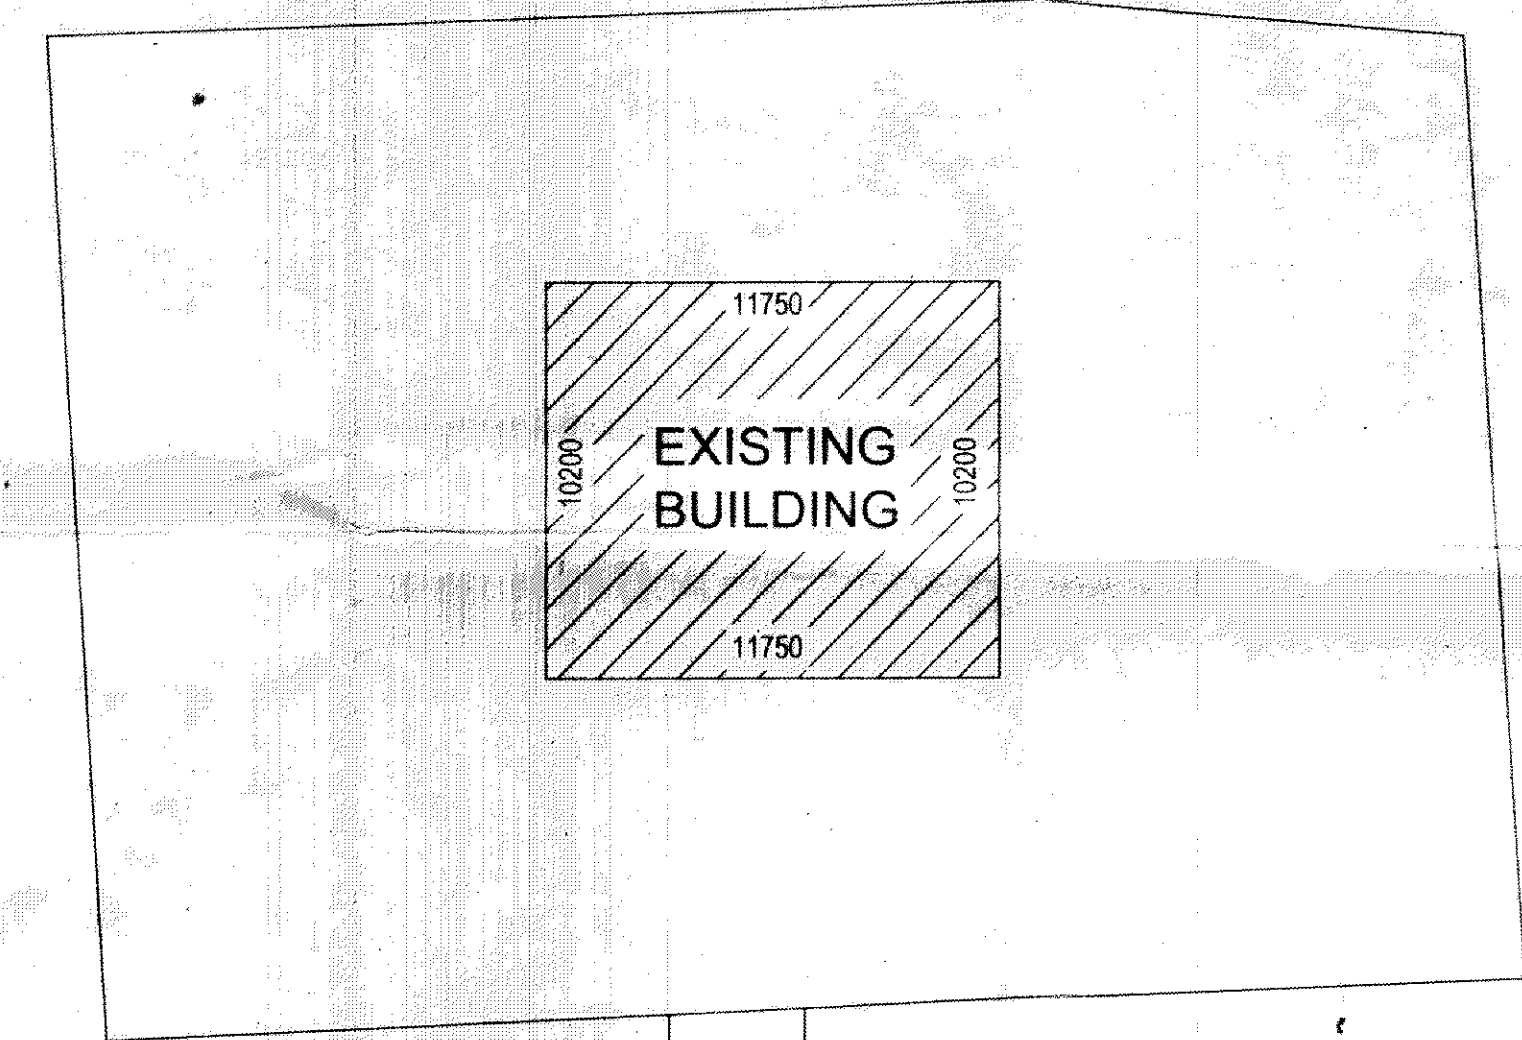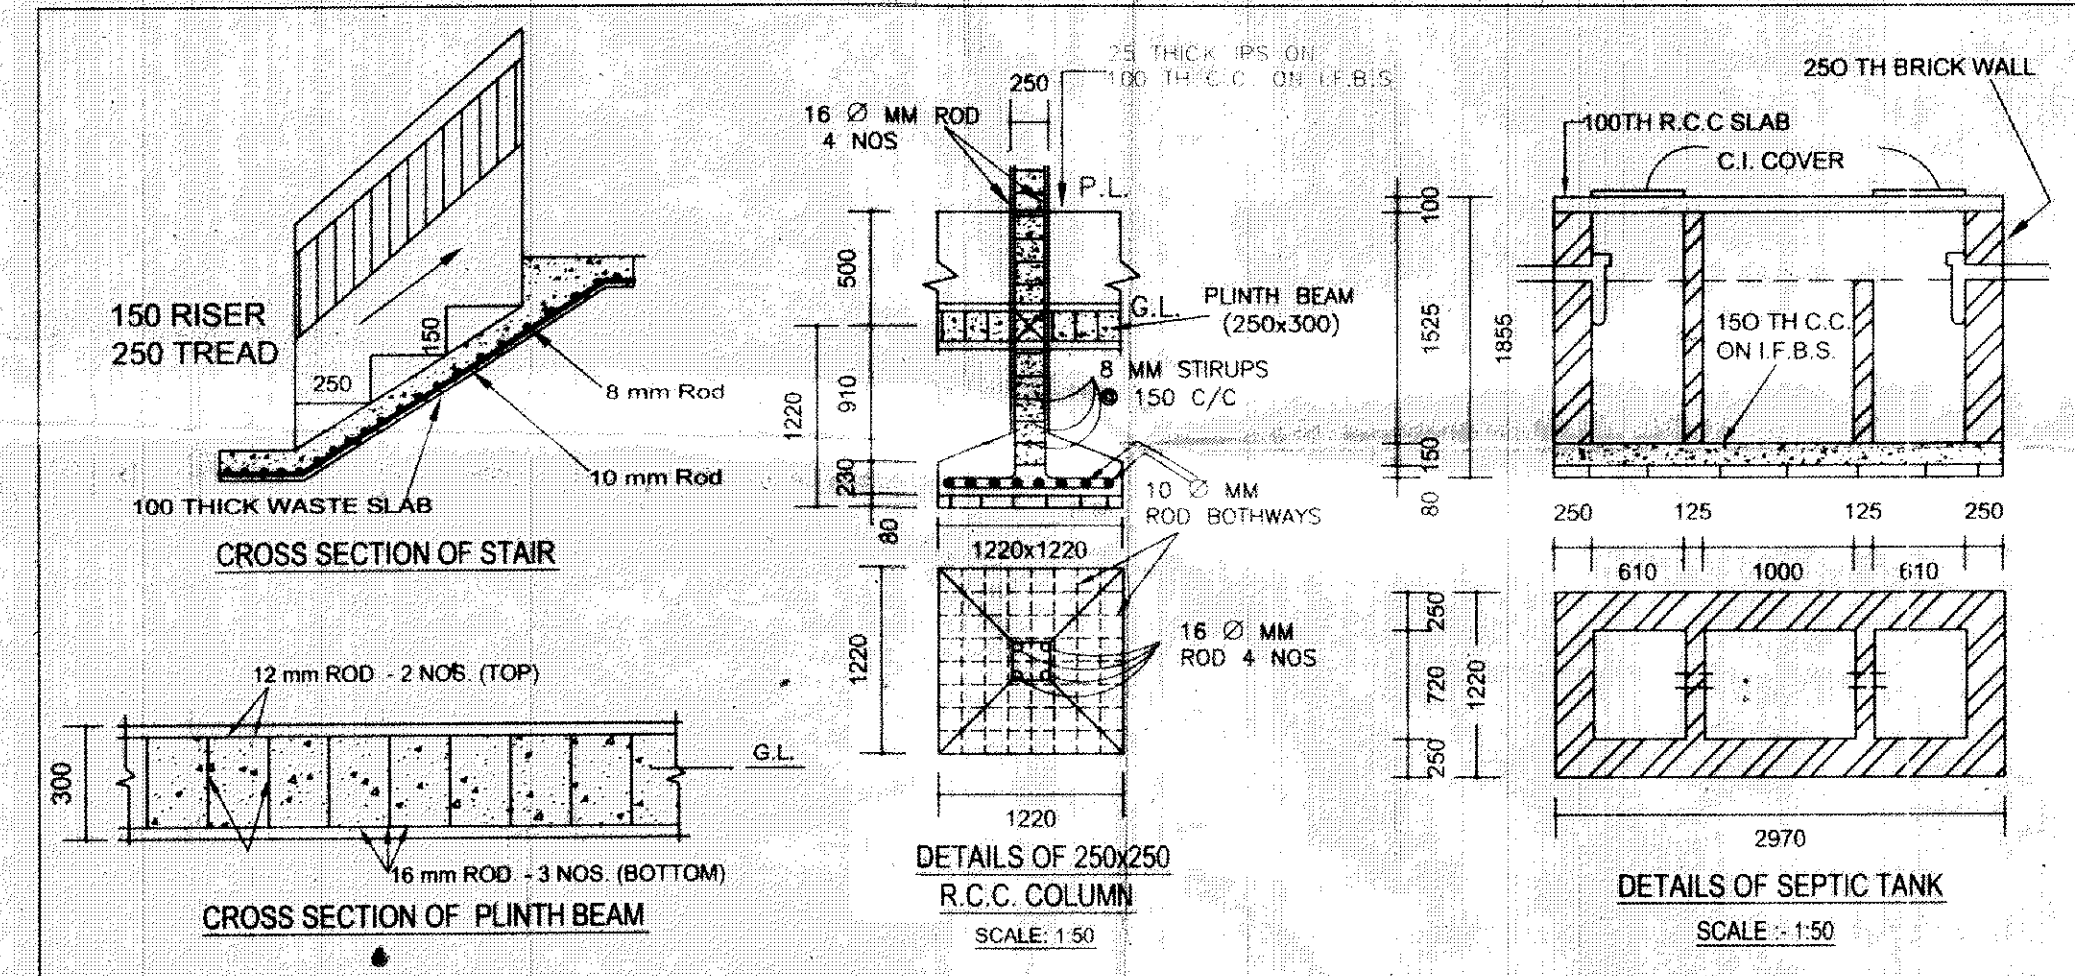

SITE PLAN
SCALE : 1:200

SCHEDULE OF DOORS & WINDOWS

TYPE	SIZES	NOS	DESCRIPTION
D	2000x1220	06	FULLY PANNELED
DI	2000x800	04	FULLY PANNELED
W	1220x2100	12	FULLY GLAZED
WI	1220x1500	02	FULLY GLAZED
WZ	600x900	04	FULLY GLAZED

NOTES:-

- ALL DIMENSIONS ARE IN MM, EXCEPT & OTHERWISE STATED BELOW.
- ALL SCALE (1:100) EXCEPT & OTHERWISE STATED BELOW.
- OWNERS PLOT IS MARKED BY RED IN COLOUR.

GENERAL NOTES:-

- ALL R.C.C. COLUMN 250x250
- 250 THK BRICK WORK IN 1:6 MORTAR
- 125 THK BRICK WORK IN 1:4 MORTAR
- R.C.C. WORK IN 1:2:4 MORTAR P.C.C. WORK IN 1:3:6 MORTAR

- STRUCTURAL SAFETY TO BE ENSURED BY THE PARTY

AREA STATEMENT

- TOTAL LAND AREA : 970.00 SQ.M
- PLINTH AREA : 120.00 SQ.M
- FIRST FLOOR AREA : 120.00 SQ.M

SCALE :- 1:100 - Plan, Elevation & Section 1:200 - Site Plan & 1:50 - Details of Septic tank & R.C.C. Column

PLAN OF EXISTING TWO STORED INSTITUTIONAL BUILDING OF "MAHANANDA COLLEGE" OVER PLOT No. 2288 (PART) J.L. NO. 92, MOUZA :- NADIHA, P.S. DURGAPUR, DIST. BURDWAN (W.B.)

Signature
Secretary
MAHANANDA COLLEGE
Kharpur 11

AUTHORISED SIGNATORY

Signature
Suman Kumar Das
Civil Engineer
For. CITY PLANNER INCORPORATION
Lic. No. Durgapur Municipal Corporation 1247
SIGNATURE OF ENGINEER
LIC.NO.DMC/247

SHEET NO. 2
DRG NO.
CP/2015/10/04/MCE/01

